

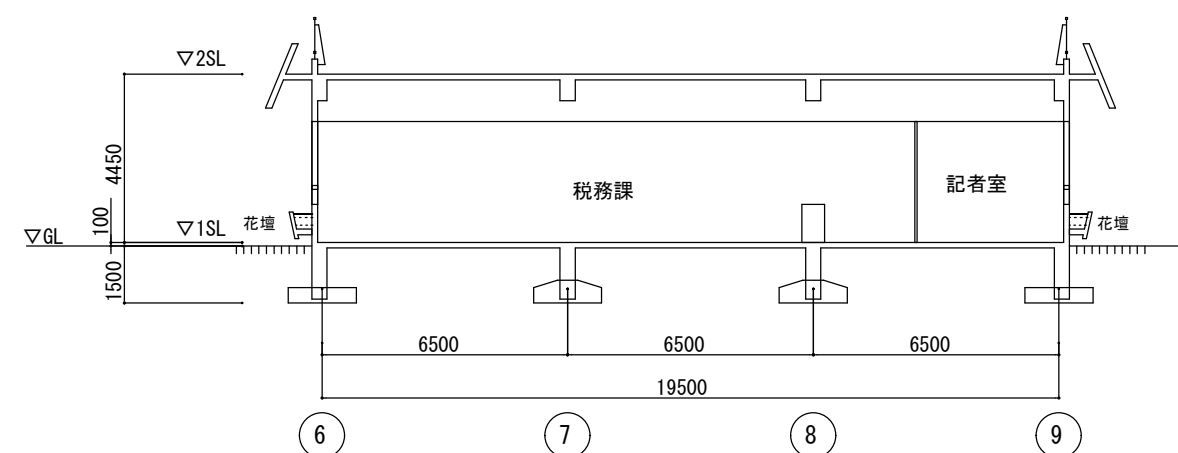
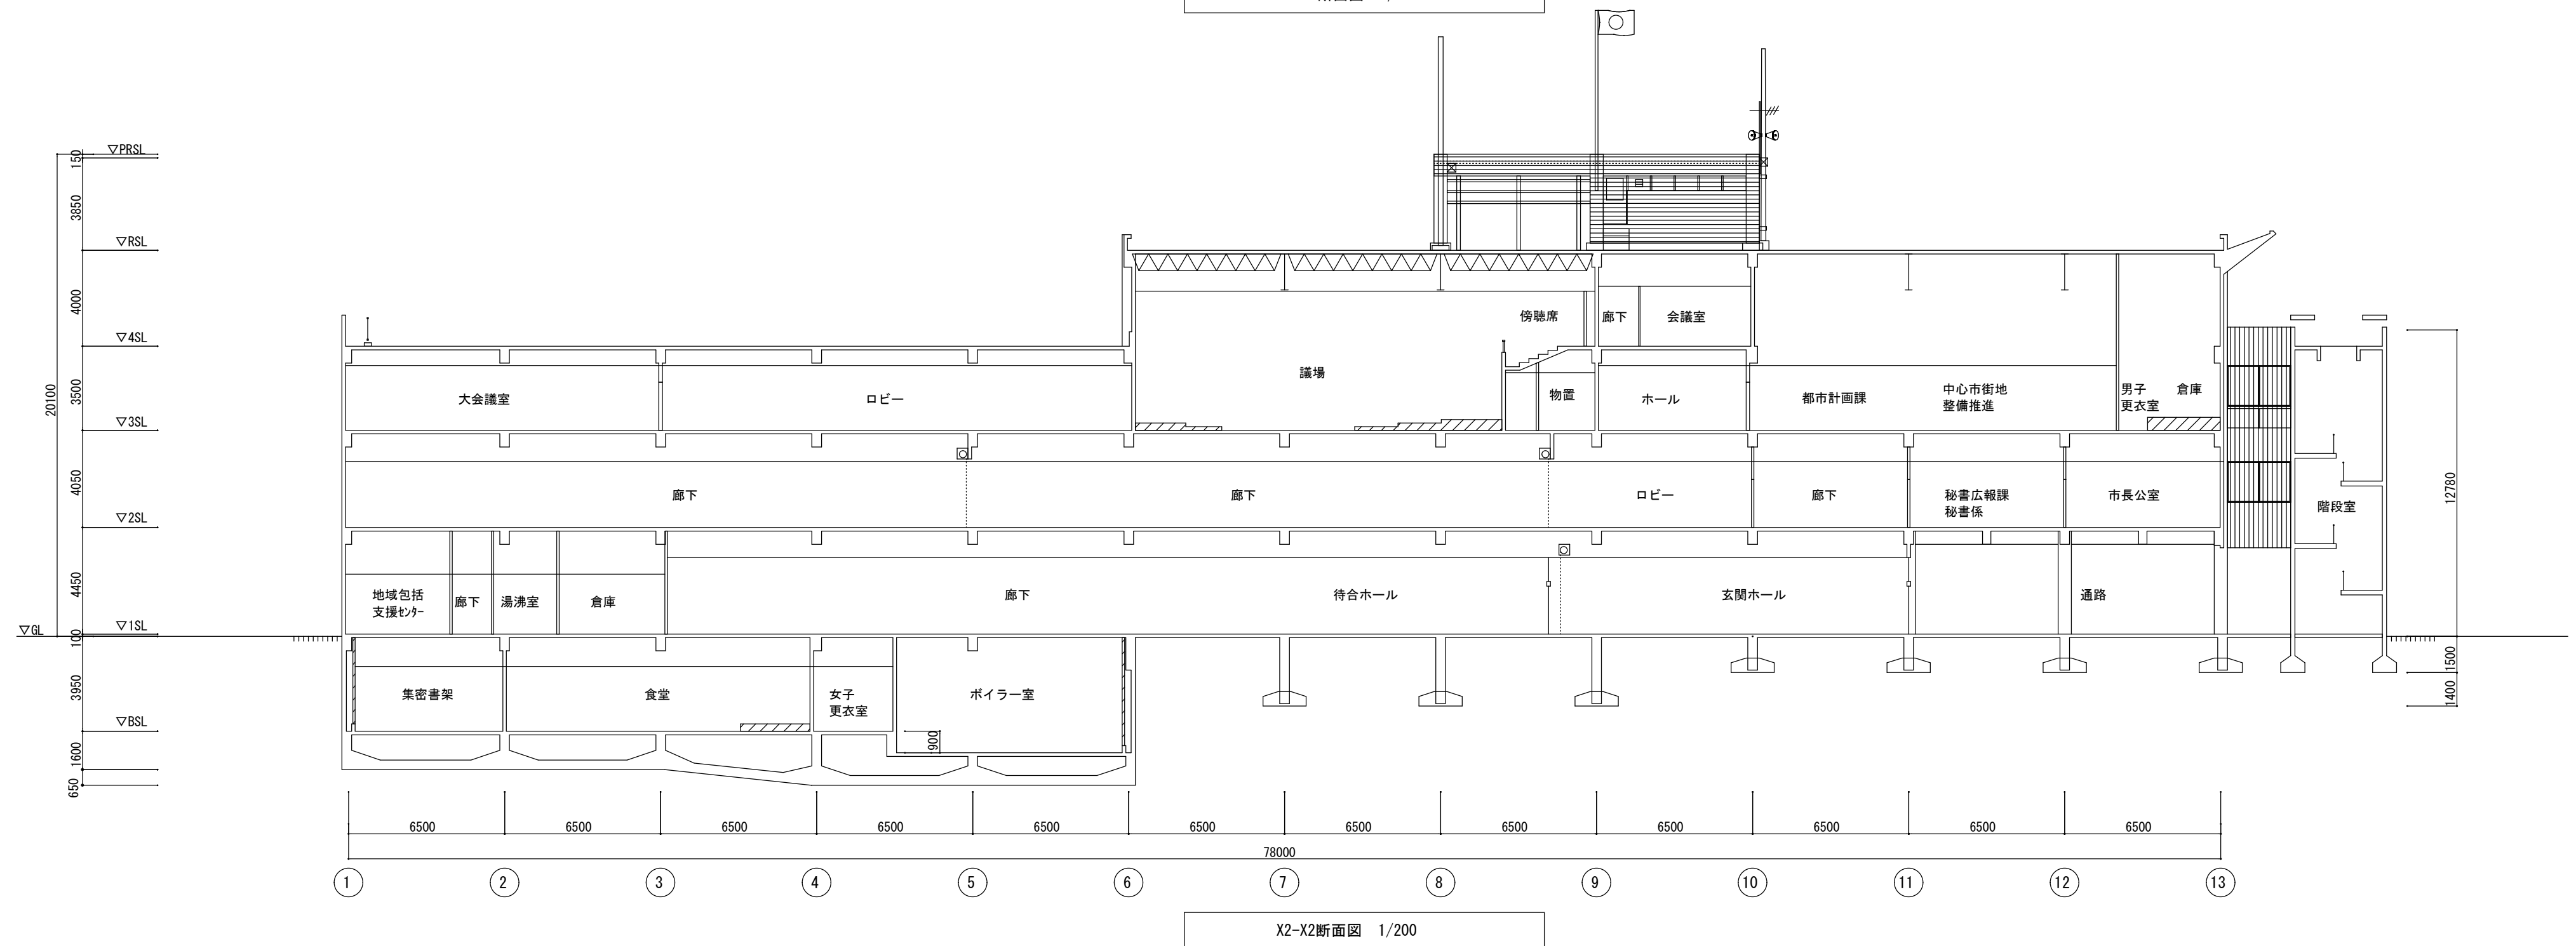
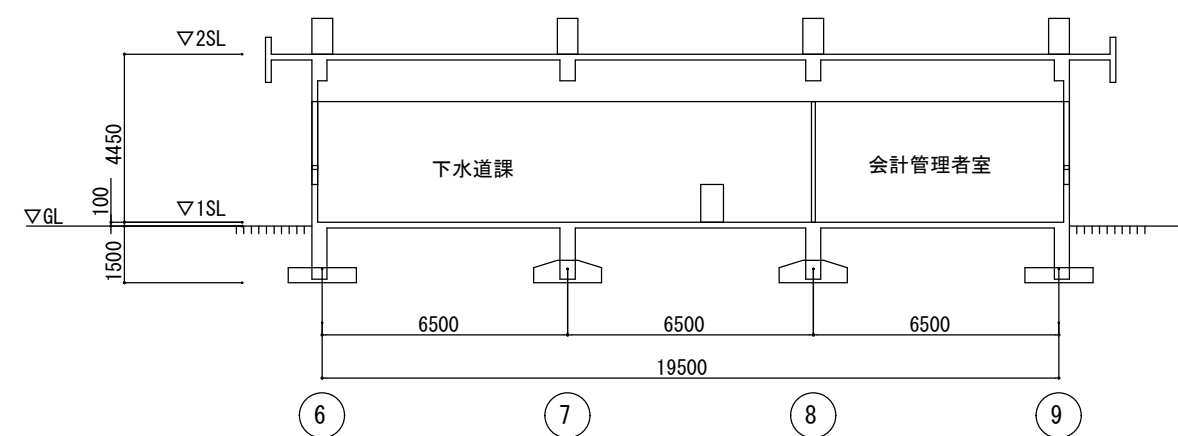
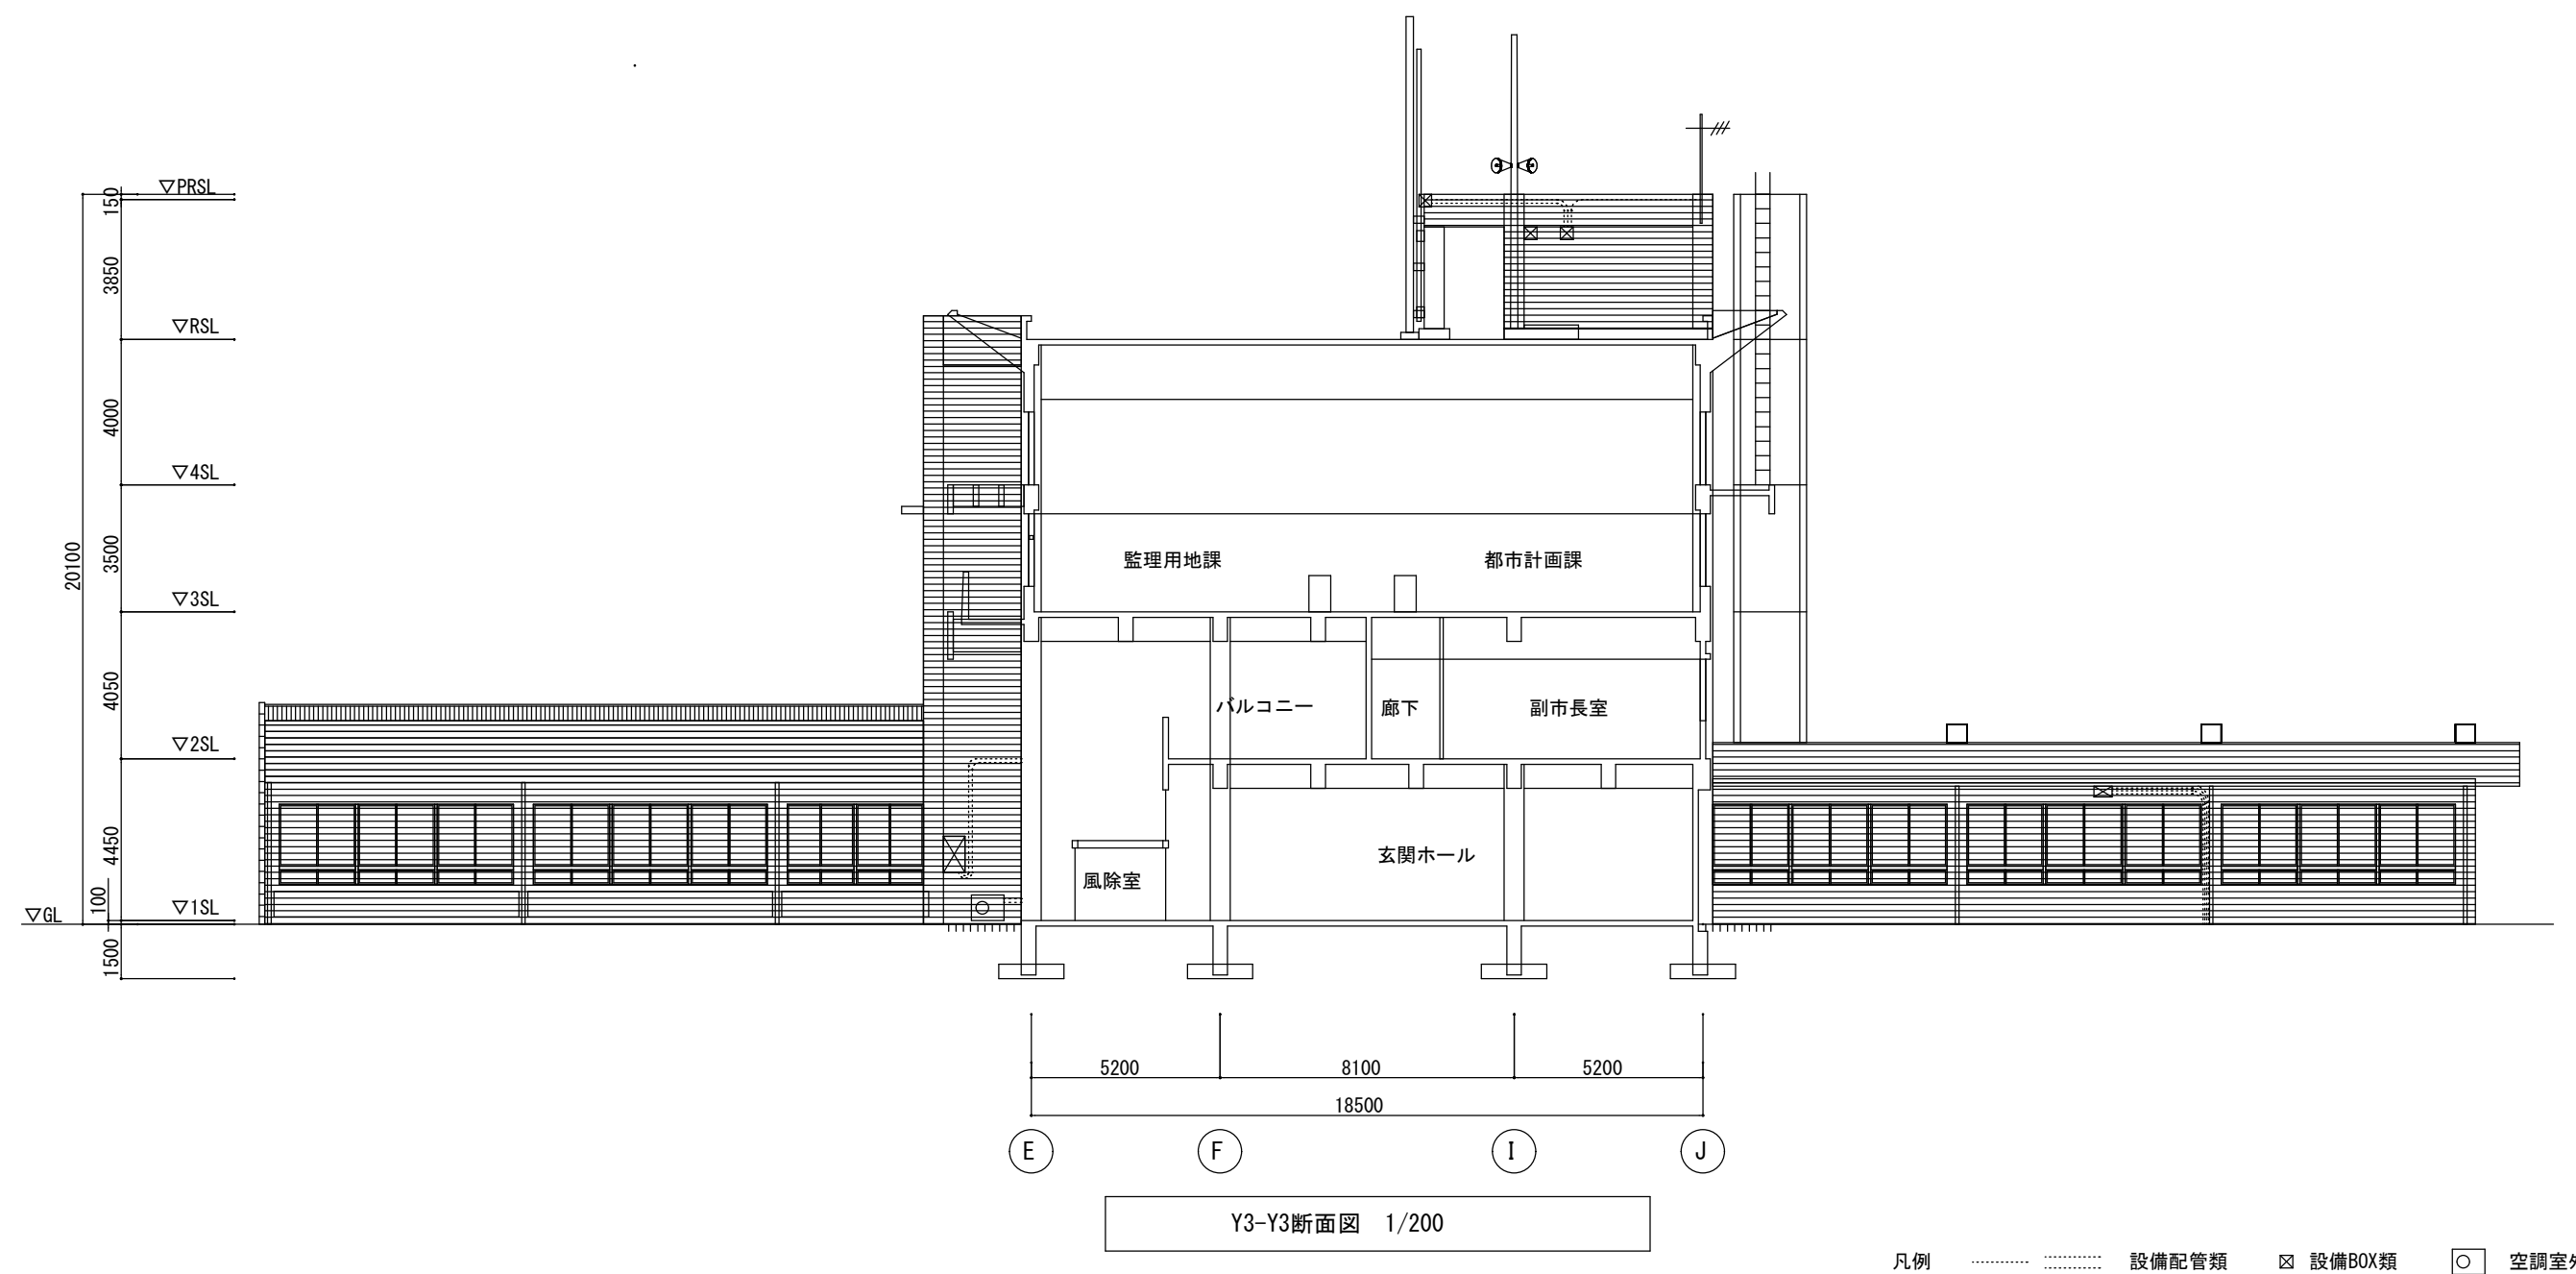


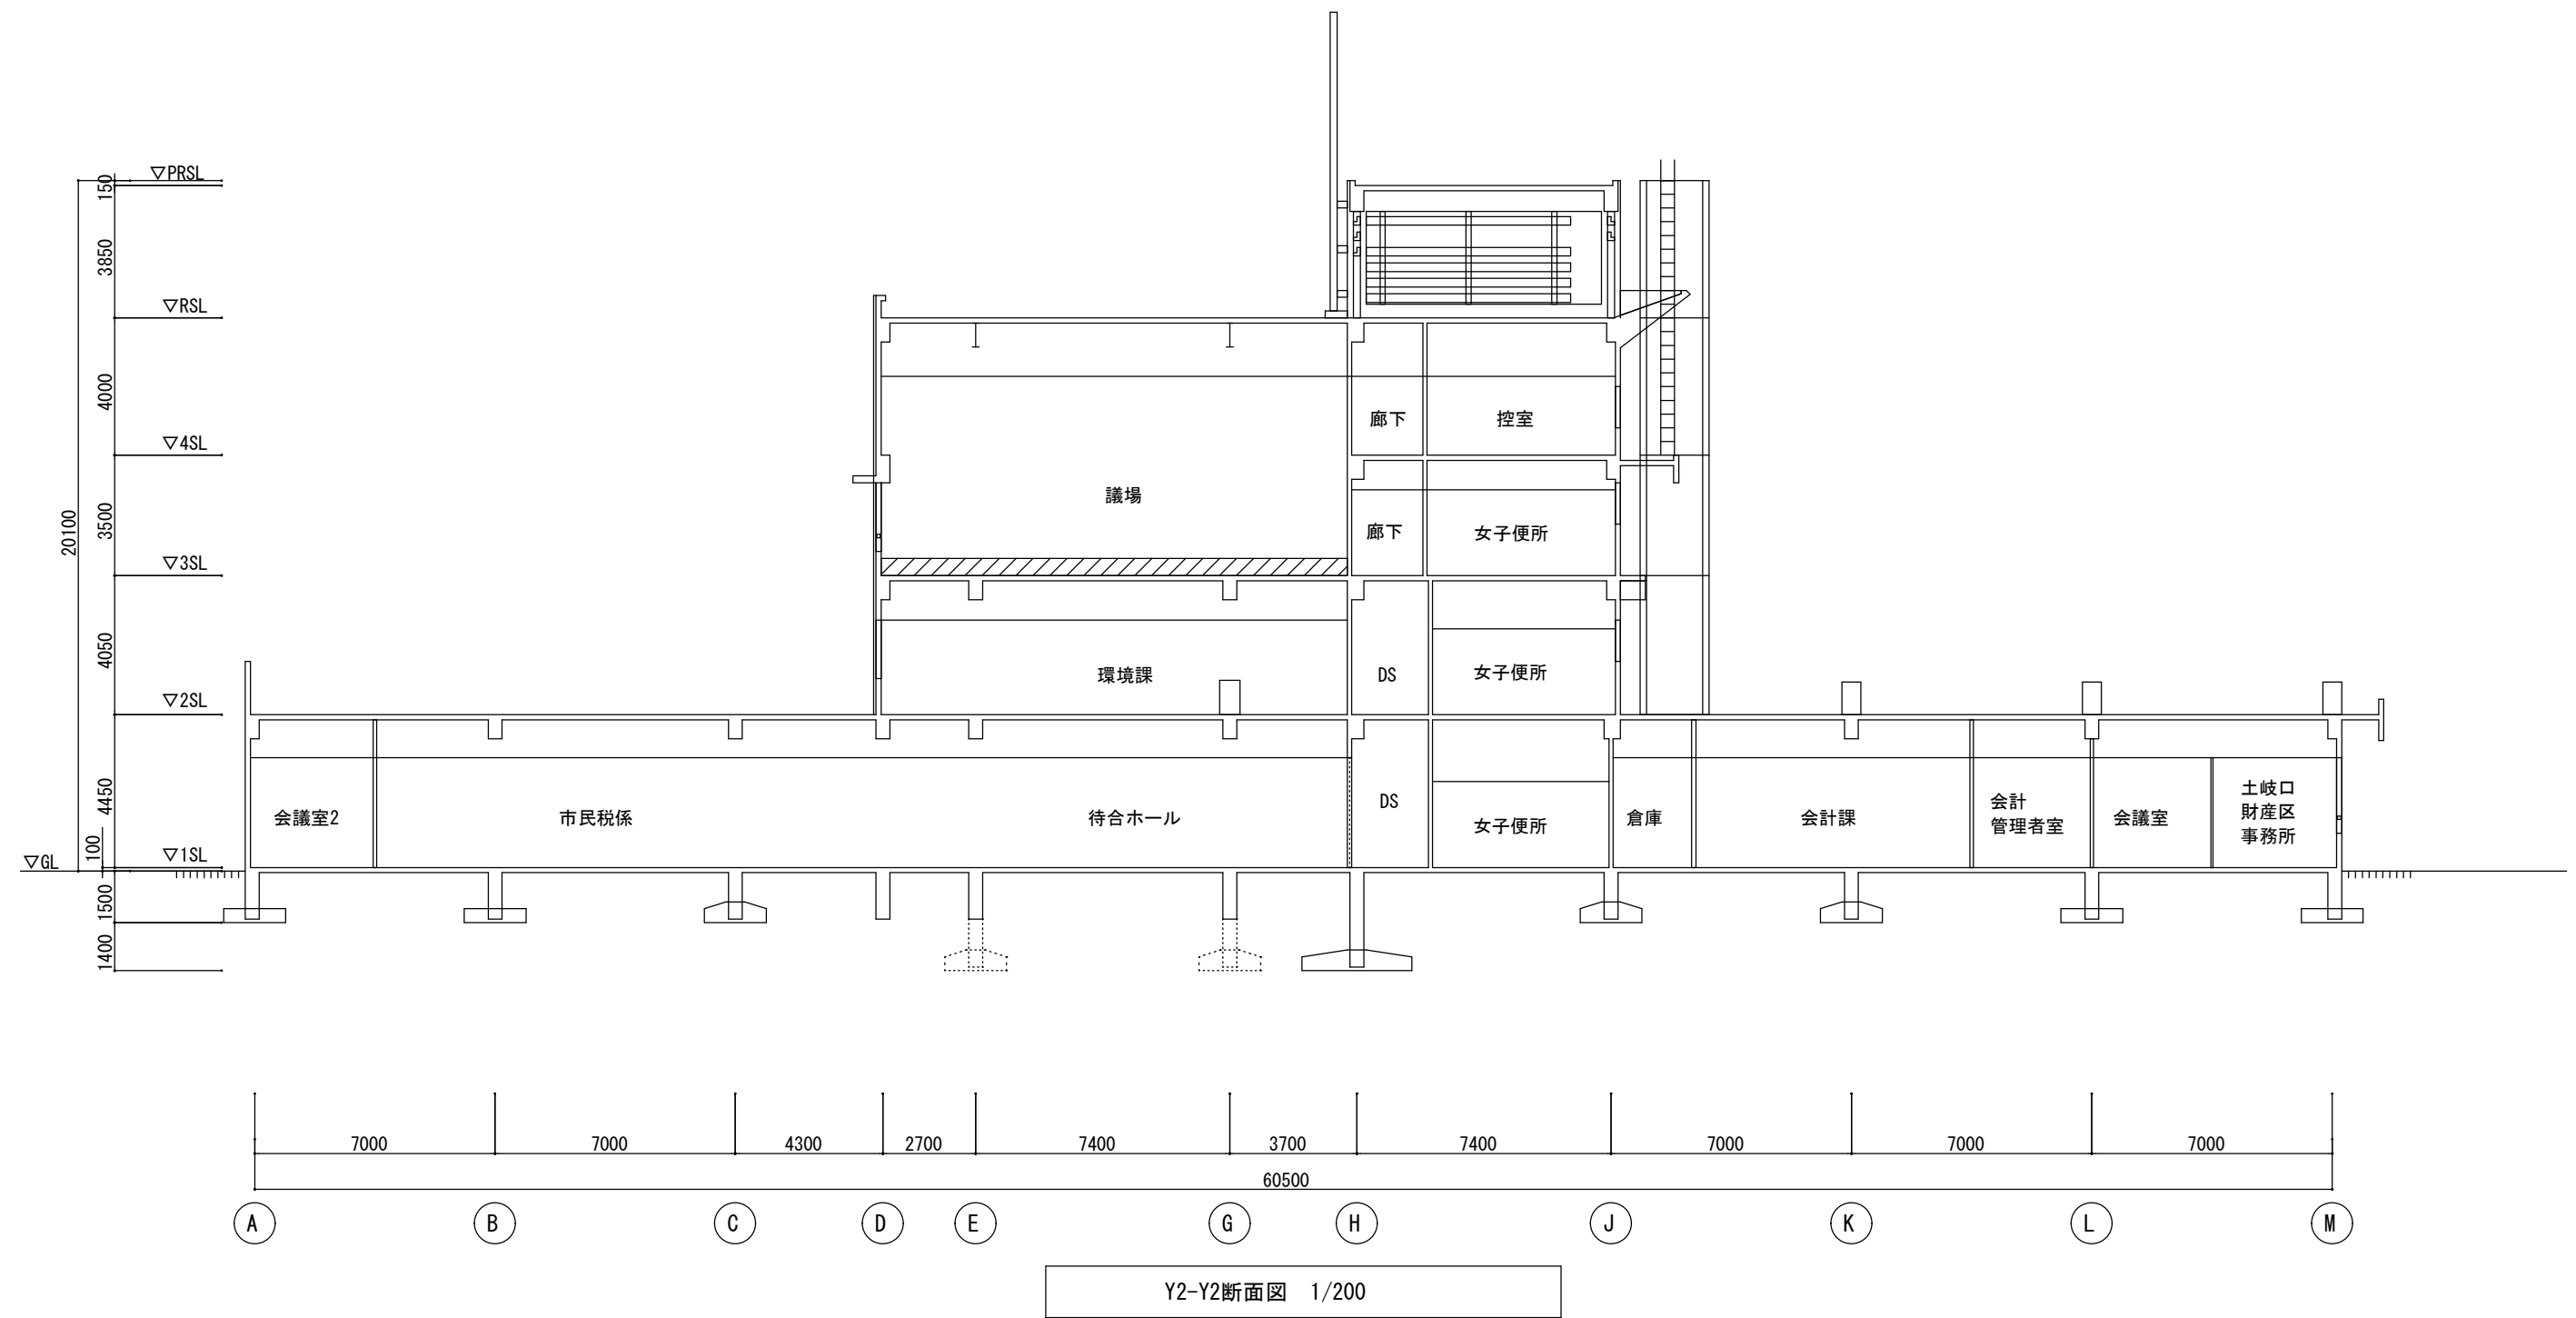

凡例 設備配管類 ☒ 設備BOX類

		/ . .	.				既設断面図 1	縮尺 1/200	図面 番 号 区 分 A-09
		/ . .	.						
	/ . .	/ . .	.						
	/ . .	/ . .	.						

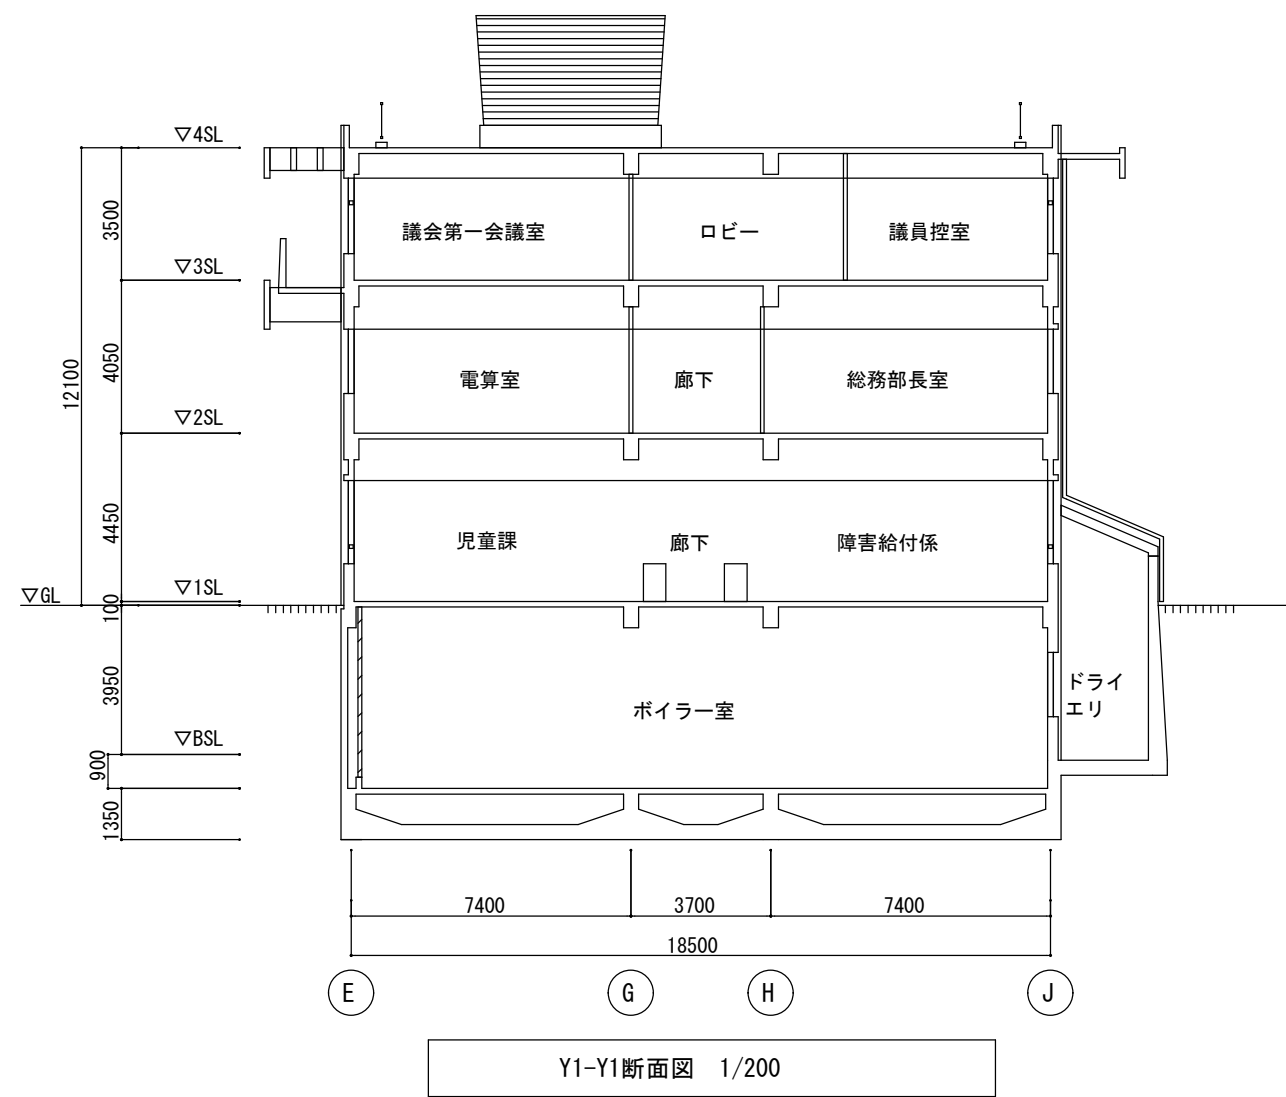

凡例 設備配管類 ☒ 設備BOX類 ☐ 空調室外機

図面内容	既設断面図 2	図面番号	A-10
縮尺	1/200	区分	